



FOUNDATION PLAN
SCALE: 3/8" = 1'-0"

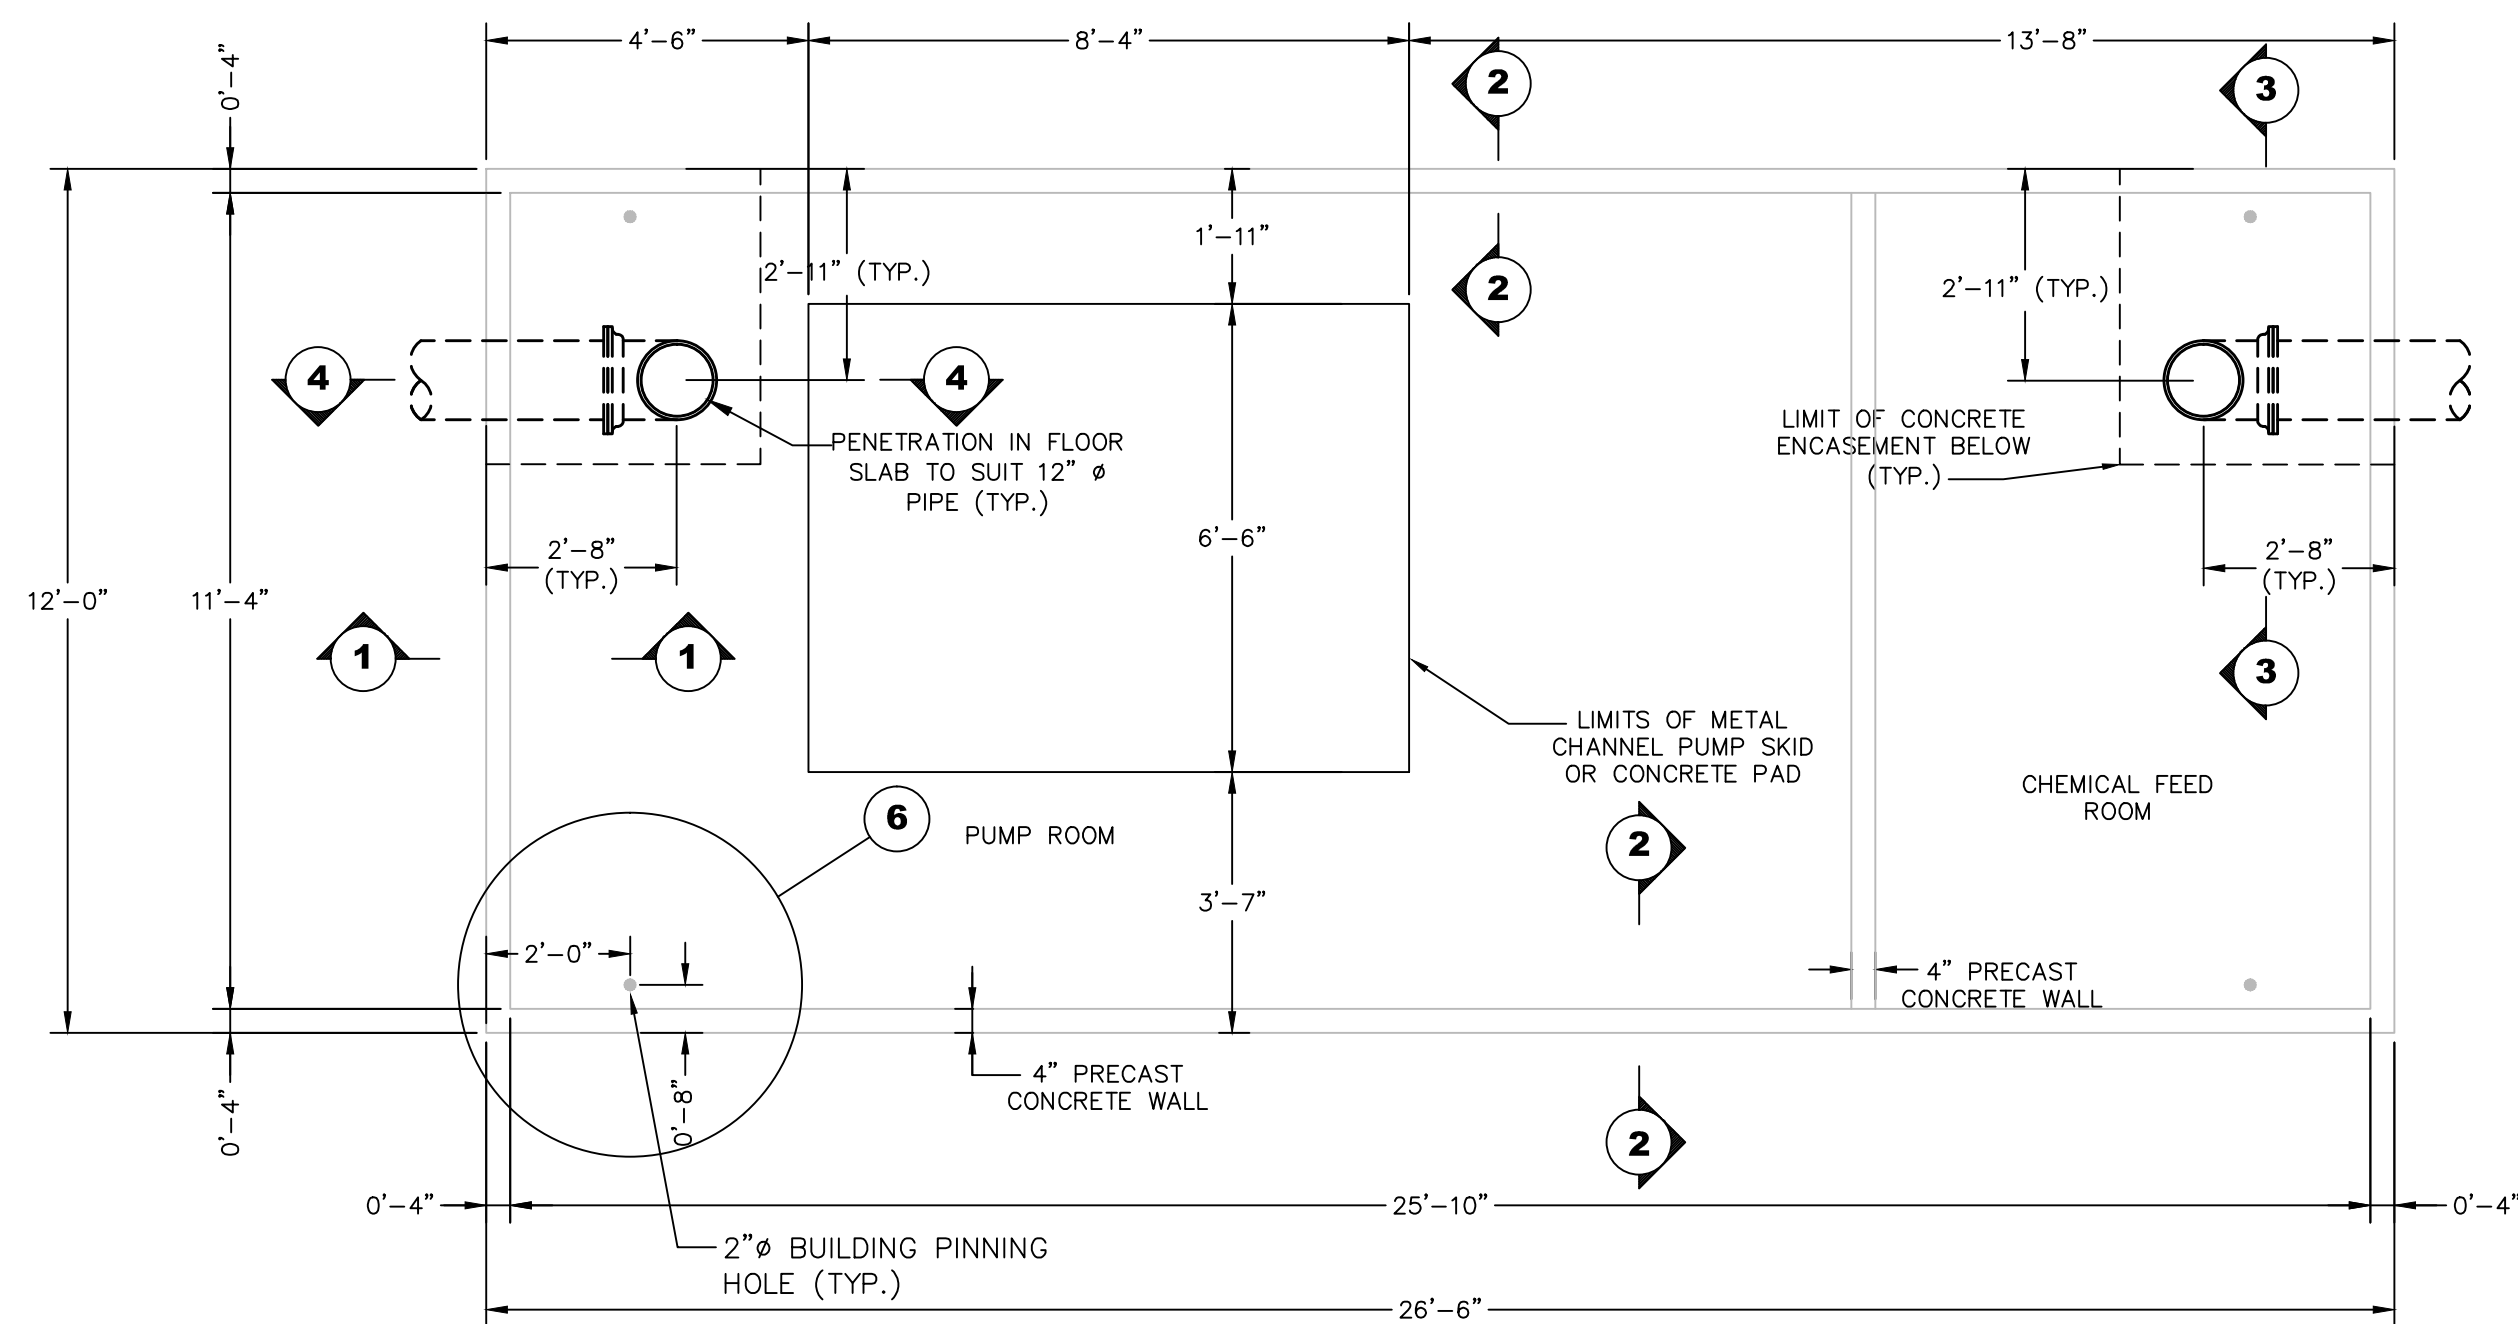


FLOOR PLAN
SCALE: 3/8" = 1'-0"

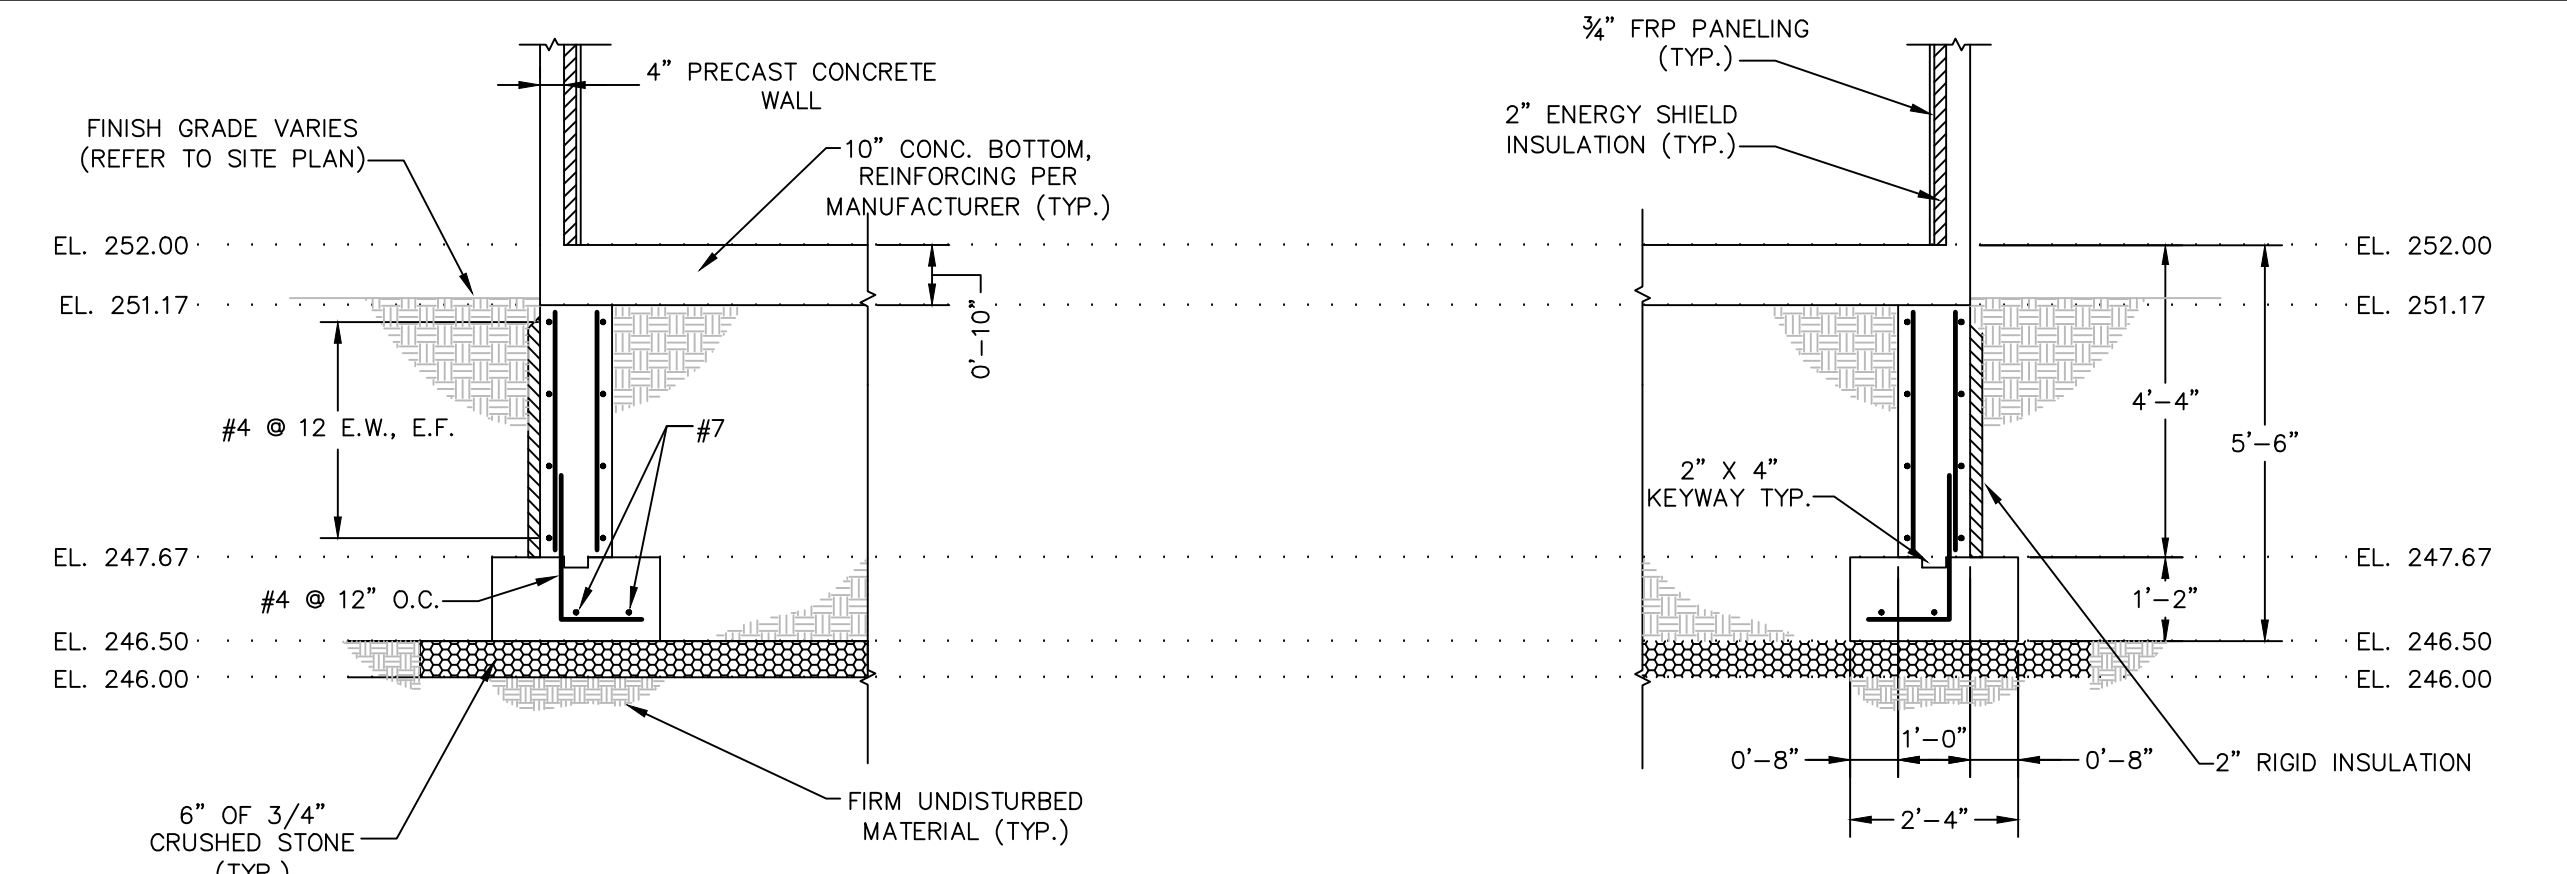

SECTION 1-1
SCALE: 3/8" = 1'-0"


SECTION 2-2
SCALE: 3/8" = 1'-0"

NOTE: WALL REINFORCING TYPICAL EXCEPT AS NOTED.

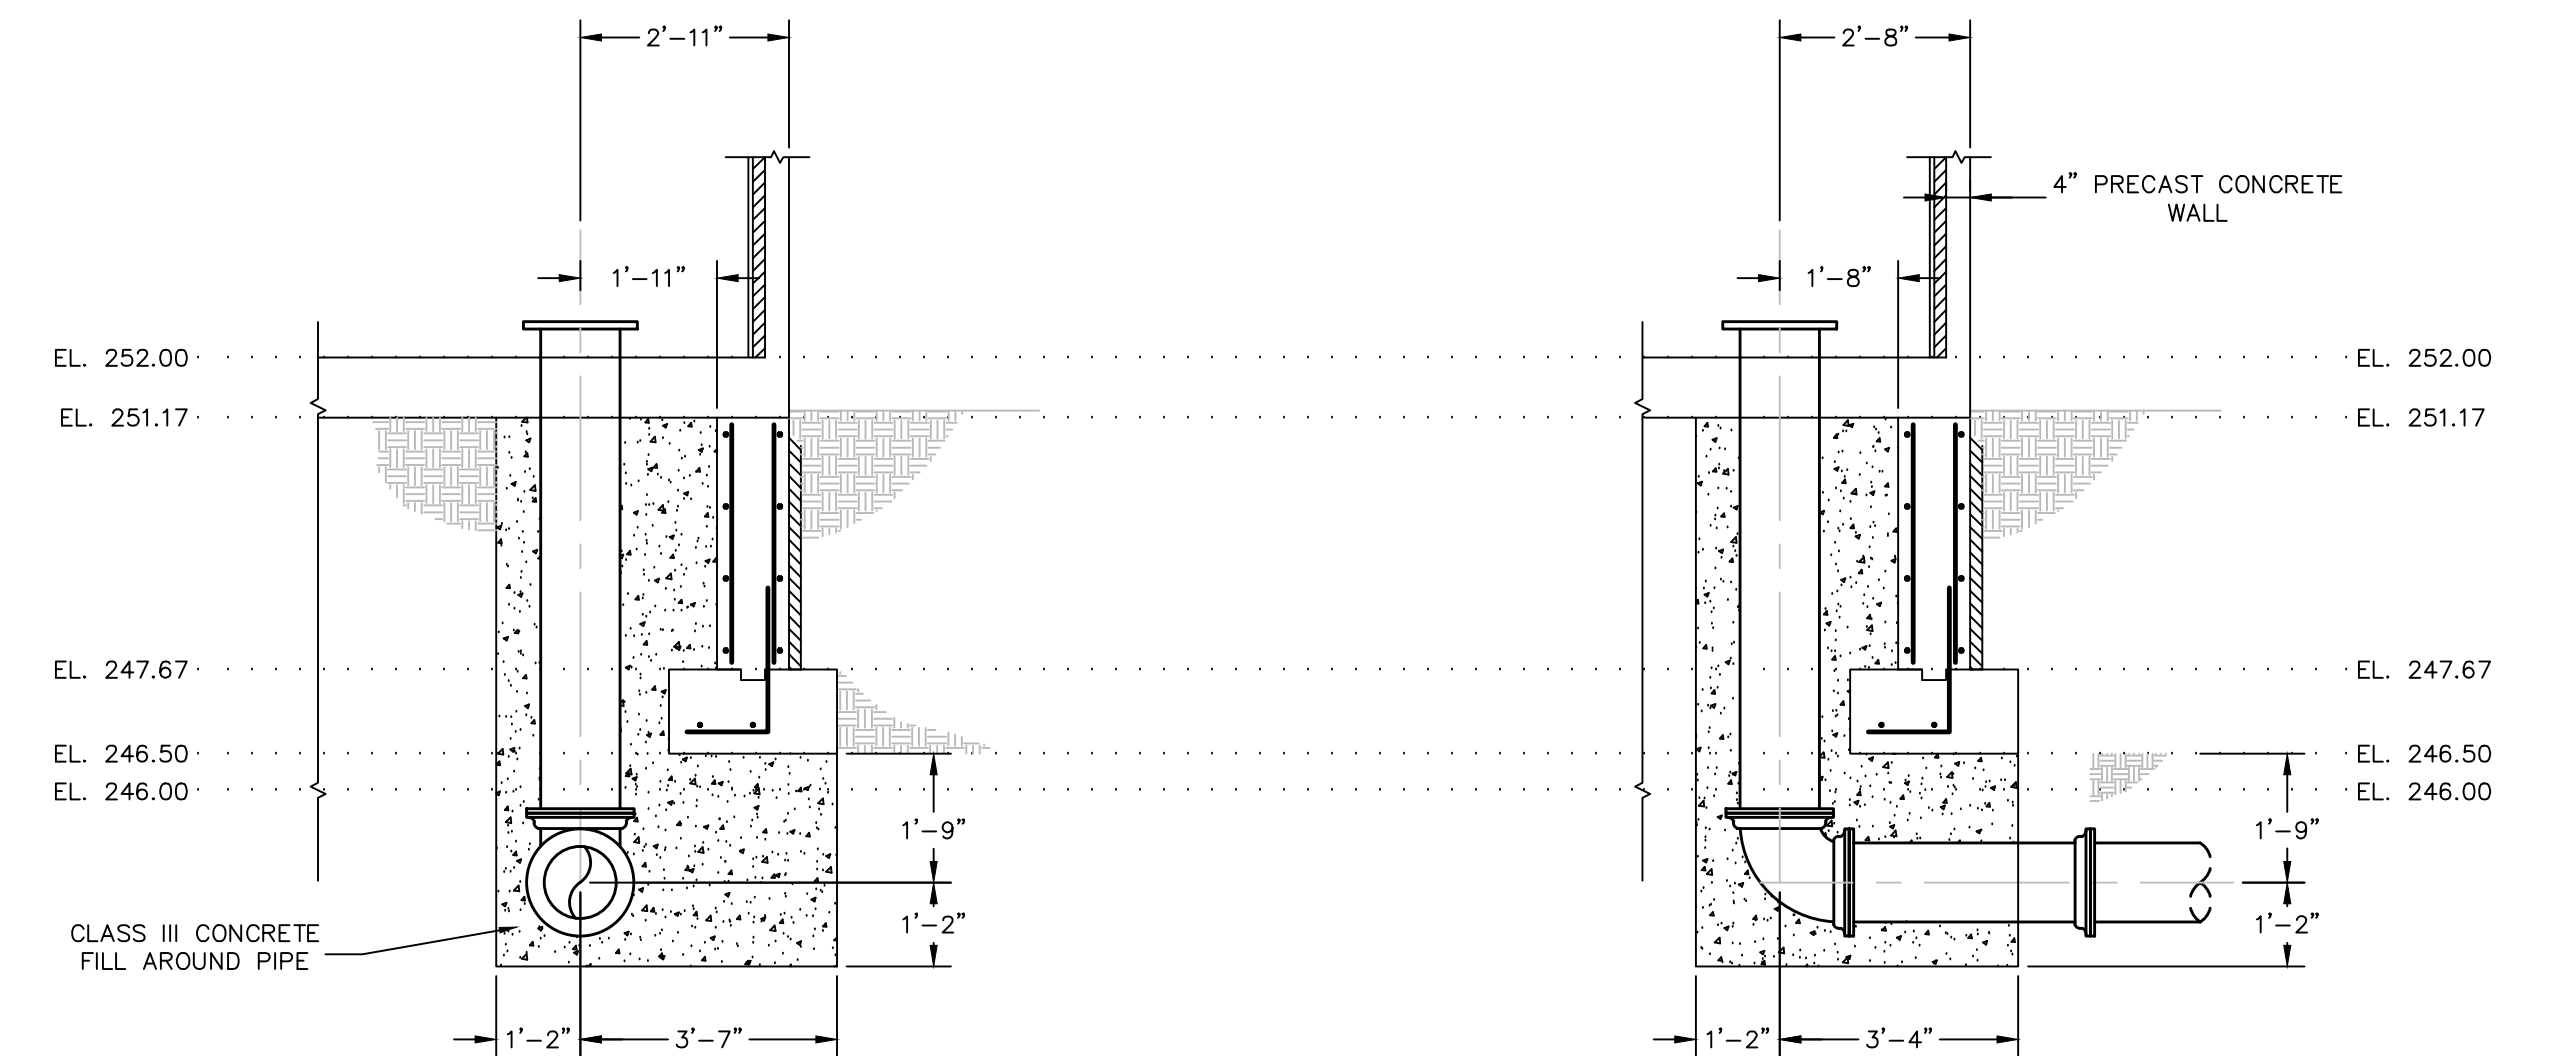

SECTION 3-3
SCALE: 3/8" = 1'-0"

SECTION 4-4
SCALE: 3/8" = 1'-0"

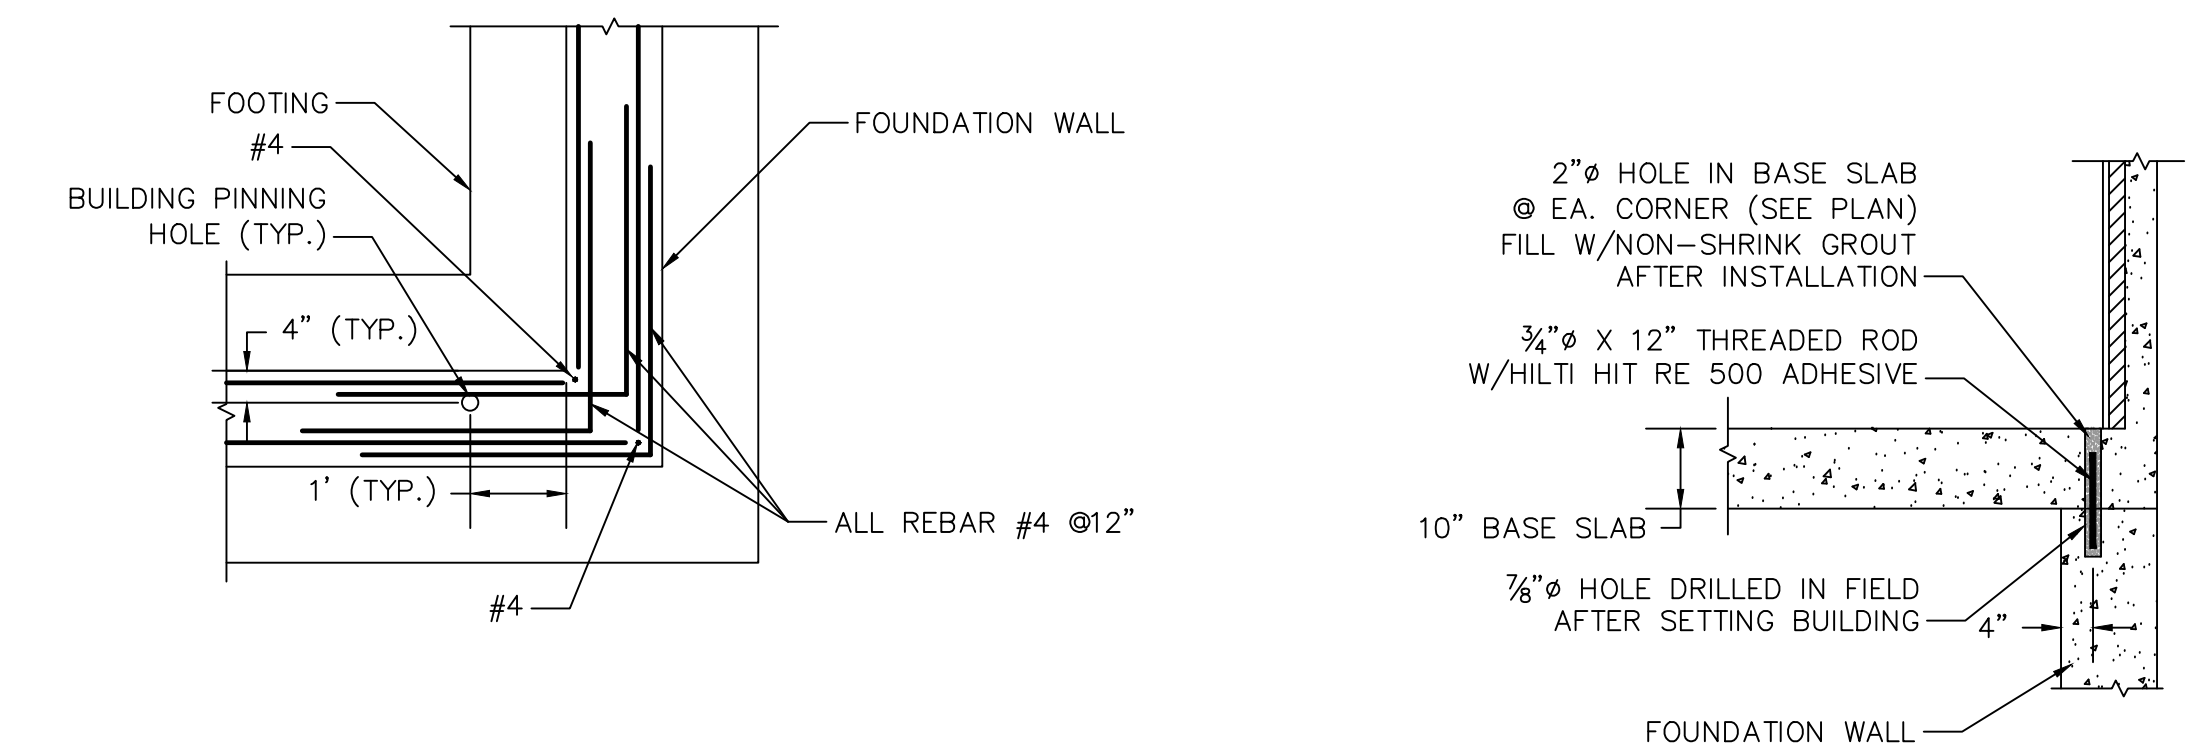


5 CORNER DETAIL
SCALE: 1/2" = 1'-0"

6 BUILDING PINNING DETAIL
SCALE: 1/2" = 1'-0"

NOTES:
1. REFER TO MECHANICAL SHEET 3 OF 5 FOR PIPING INFORMATION.
2. FOUNDATION FOOTING AND WALL TO BE CONSTRUCTED PRIOR TO PLACEMENT OF PIPING/CONCRETE FILL.

REVISIONS		
NO.	ITEM	DATE
1	REDESIGN AS NEW BPS	9/27/12
2	GU COMMENTS / TWO BUILDINGS	11/6/12
3	CT DPH SUBMITTAL	12/17/12
4	ISSUED FOR BIDDING	3/7/13
5	ISSUED FOR DPH REVIEW / REBID	4/30/13

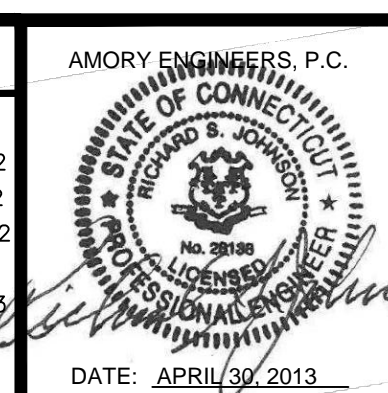

AMORY ENGINEERS, P.C. DUXBURY, MASSACHUSETTS		
DRAWN BY: PGB	FILE NAME: AS SHOWN	SCALE: AS SHOWN
DESIGNED BY: RSJ/PGB	JOB NO.: 3331	DWG. NO.: 1649
CHECKED BY: RSJ	DATE: 9/27/12	CONTRACT: 2013-03 (REBID)

WATER POLLUTION CONTROL AUTHORITY LEDYARD, CONNECTICUT
CONSTRUCTION OF BOOSTER PUMPING STATION TO SERVE ALJEN HEIGHTS WATER EXTENSION
PLANS, SECTIONS AND DETAILS

STRUCTURAL
SHEET
2 OF 5