


TRENCH WIDTH TABLE		
PIPE DIA.	12" & UNDER	16"
TRENCH WIDTH	4'-0"	4'-4"

**WATERMAIN TRENCH DETAIL**  
NOT TO SCALE

**HOLMBERG ORCHARD**

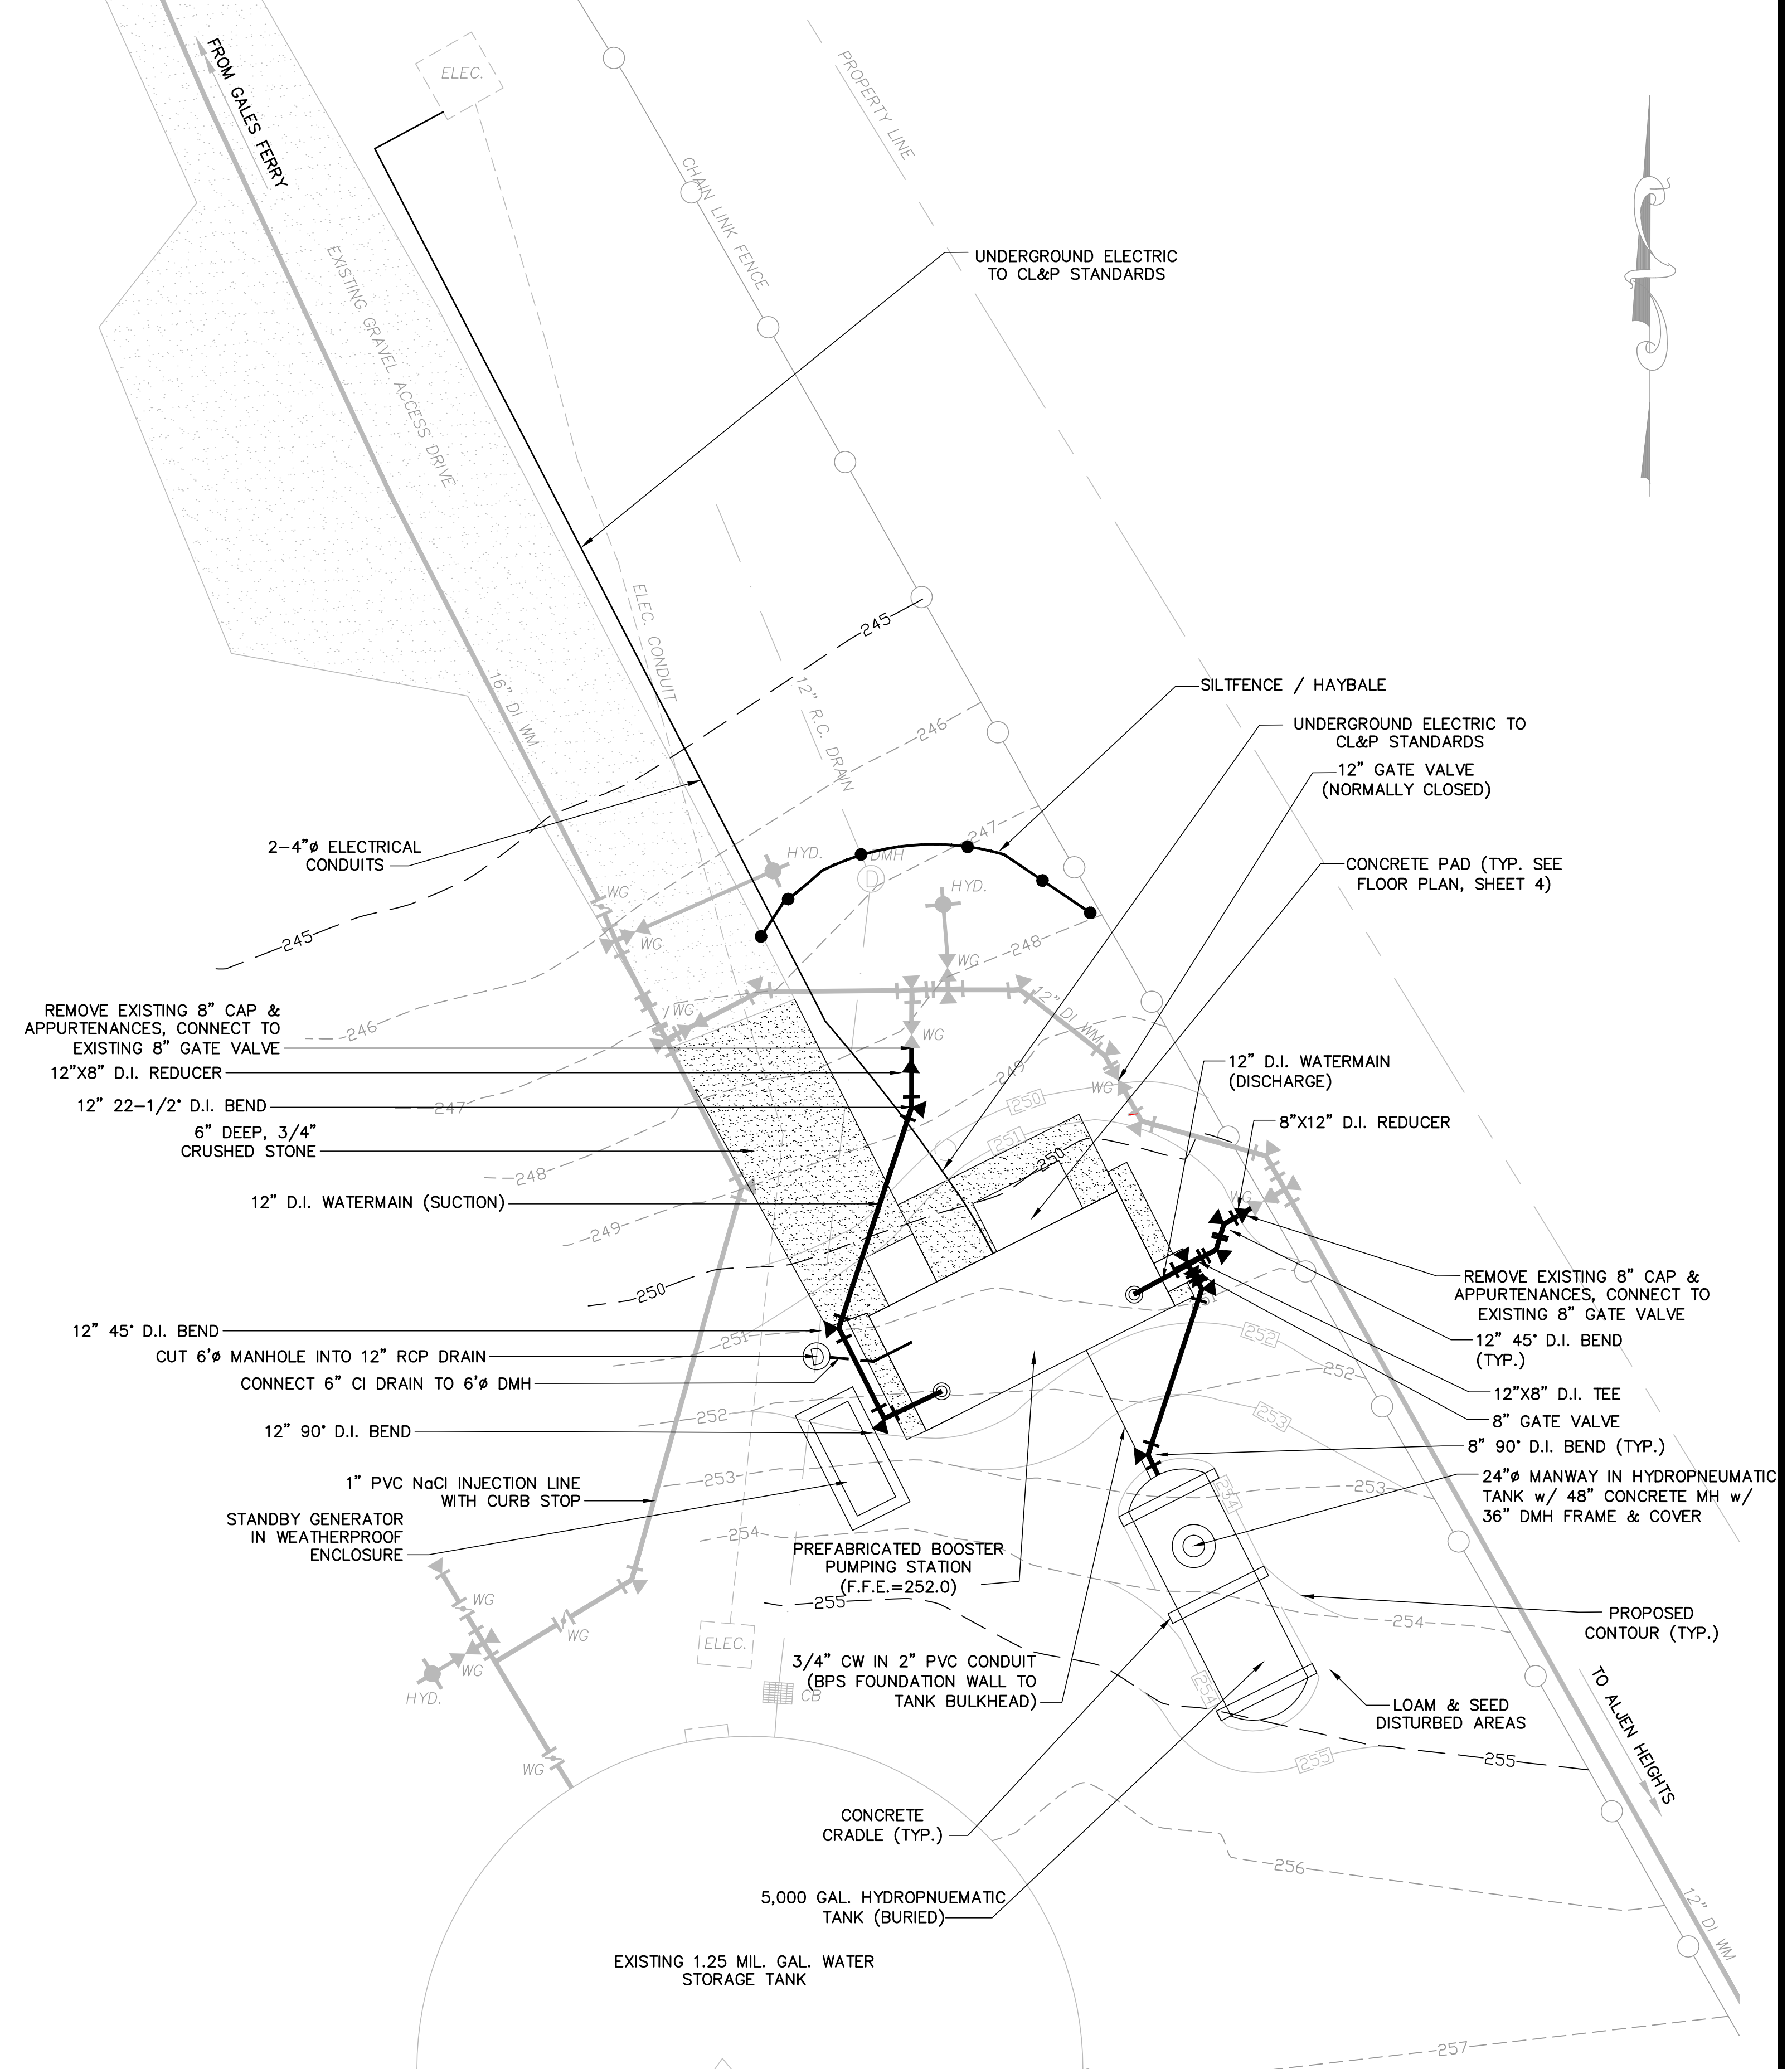

**PROPOSED SITE PLAN**  
SCALE: 1" = 10'-0"

<b>REVISIONS</b> <table border="1"> <thead> <tr> <th>NO.</th> <th>ITEM</th> <th>DATE</th> </tr> </thead> <tbody> <tr> <td>1</td> <td>REDESIGN AS NEW BPS</td> <td>9/27/12</td> </tr> <tr> <td>2</td> <td>GU COMMENTS / TWO BUILDINGS</td> <td>11/6/12</td> </tr> <tr> <td>3</td> <td>CT DPH SUBMITTAL</td> <td>12/17/12</td> </tr> <tr> <td>4</td> <td>ISSUED FOR BIDDING</td> <td>3/7/13</td> </tr> <tr> <td>5</td> <td>ISSUED FOR DPH REVIEW / REBID</td> <td>4/30/13</td> </tr> </tbody> </table>		NO.	ITEM	DATE	1	REDESIGN AS NEW BPS	9/27/12	2	GU COMMENTS / TWO BUILDINGS	11/6/12	3	CT DPH SUBMITTAL	12/17/12	4	ISSUED FOR BIDDING	3/7/13	5	ISSUED FOR DPH REVIEW / REBID	4/30/13	<b>AMORY ENGINEERS, P.C.</b> DUXBURY, MASSACHUSETTS DRAWN BY: PGB DESIGNED BY: RSJ/PGB CHECKED BY: RSJ FILE NAME: AS SHOWN JOB NO.: 3331 DATE: 9/27/12 SCALE: AS SHOWN DWG. NO.: 1531 CONTRACT: 2013-03 (REBID)		<b>WATER POLLUTION CONTROL AUTHORITY</b> LEDYARD, CONNECTICUT CONSTRUCTION OF BOOSTER PUMPING STATION TO SERVE ALJEN HEIGHTS WATER EXTENSION SITE PLAN AND DETAILS		CIVIL SHEET 1 OF 5	
NO.	ITEM	DATE																							
1	REDESIGN AS NEW BPS	9/27/12																							
2	GU COMMENTS / TWO BUILDINGS	11/6/12																							
3	CT DPH SUBMITTAL	12/17/12																							
4	ISSUED FOR BIDDING	3/7/13																							
5	ISSUED FOR DPH REVIEW / REBID	4/30/13																							

C:\000386-1\admin\LOCALS\1\Temp\NoPubPlan\_3861\_3331\_R680 Final Site Plan\_2013.dwg